

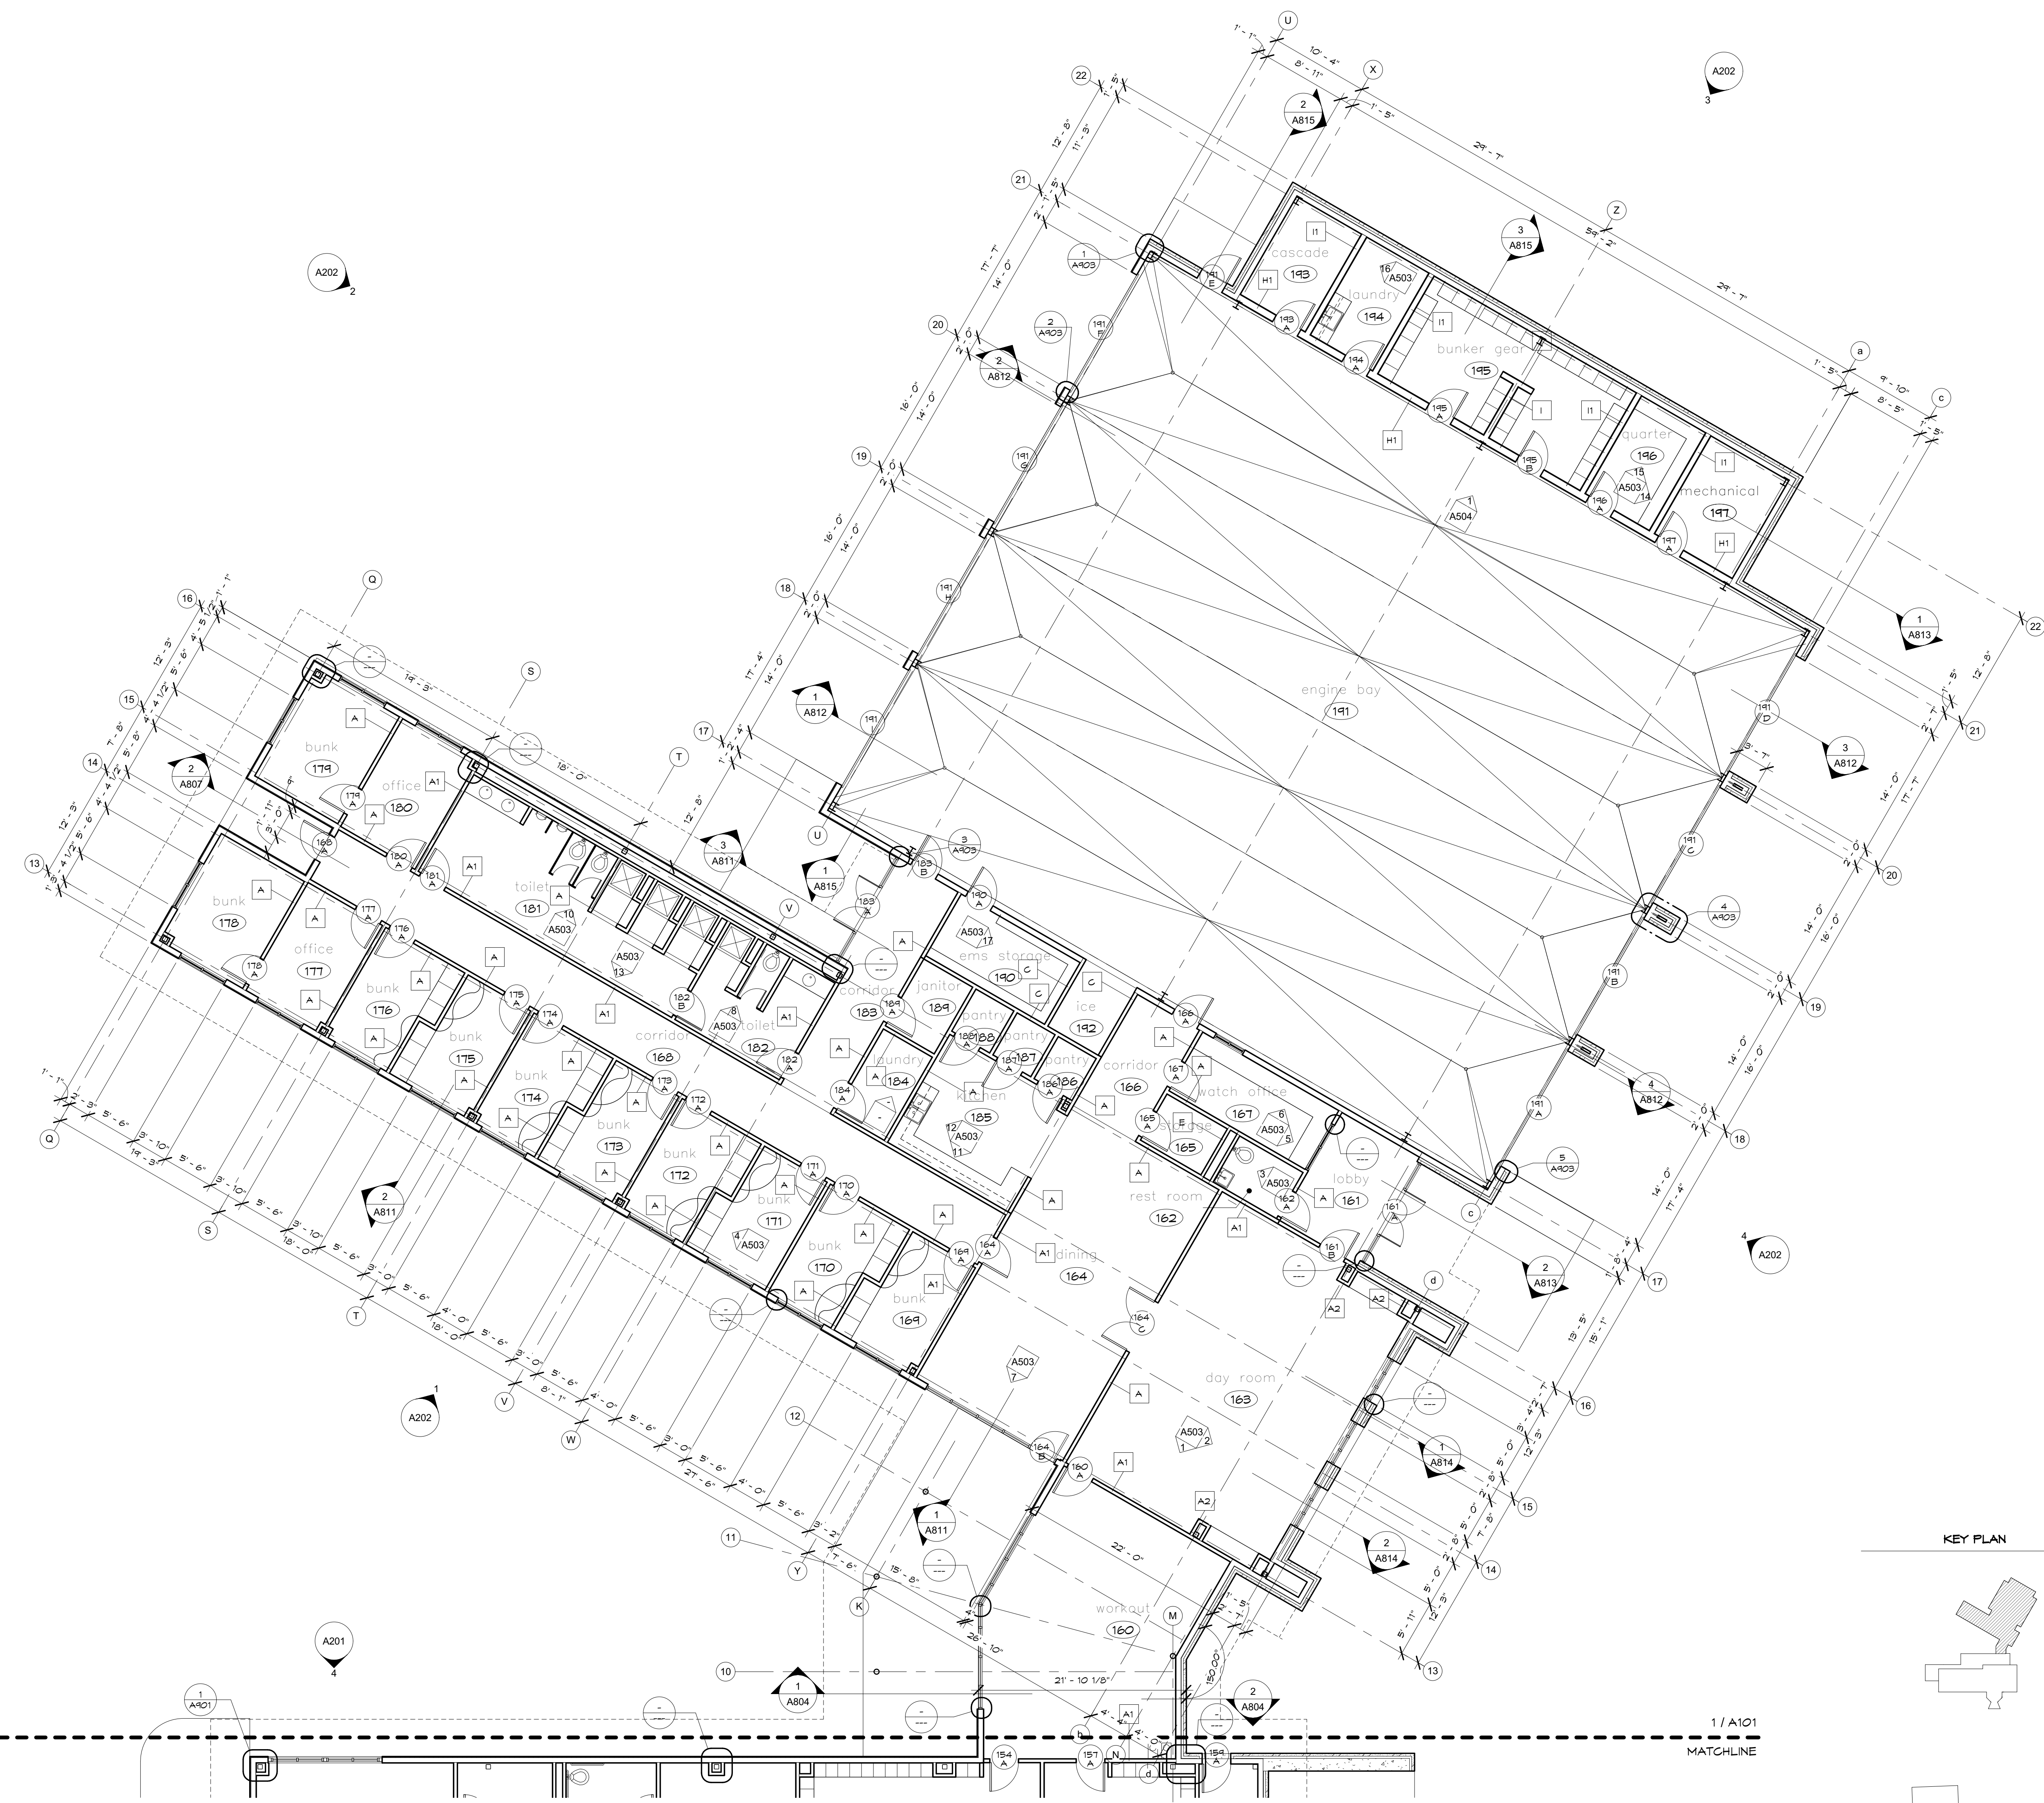


**SACHSE PUBLIC SAFETY
BUILDING
SACHSE TEXAS**


RON HOBBS ARCHITECTS
614 WEST MAIN STREET, SUITE 200
GARLAND, TEXAS 75040
PHONE: 972-494-0174 www.ronhobbsarchitects.net FAX: 972-494-0722

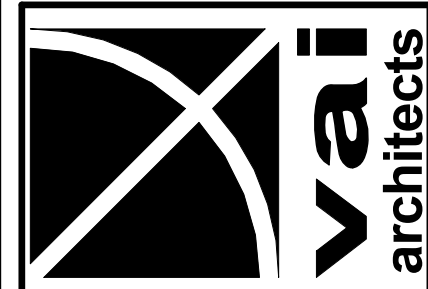

KEY PLAN

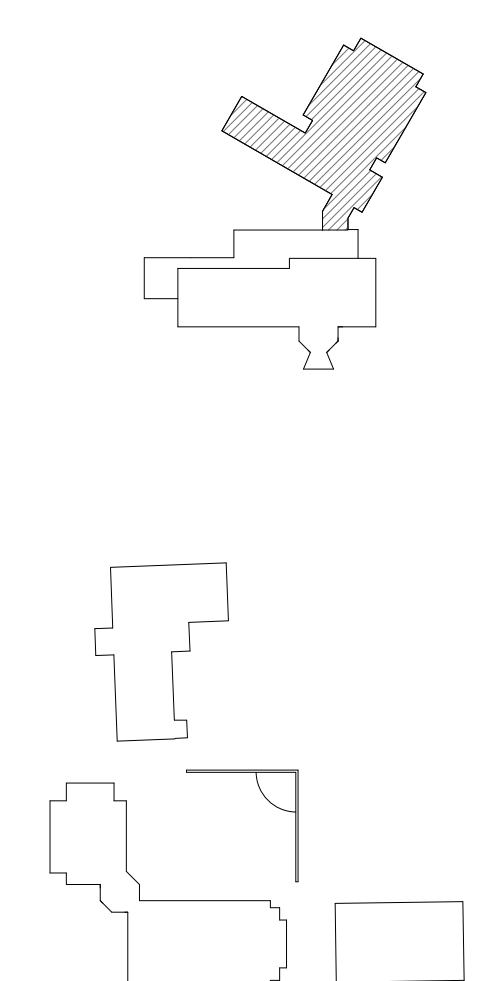

1 FIRE STATION LOWER LEVEL
FLOOR PLAN
SCALE: 1/8" = 1'-0"

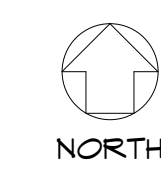

1 / A101
MATCHLINE

1 / A101
MATCHLINE

JOB NUMBER
SACHSE PUBLIC SAFETY
BUILDING
0723

SHEET NUMBER
FIRE STATION FLOOR PLAN
A103